


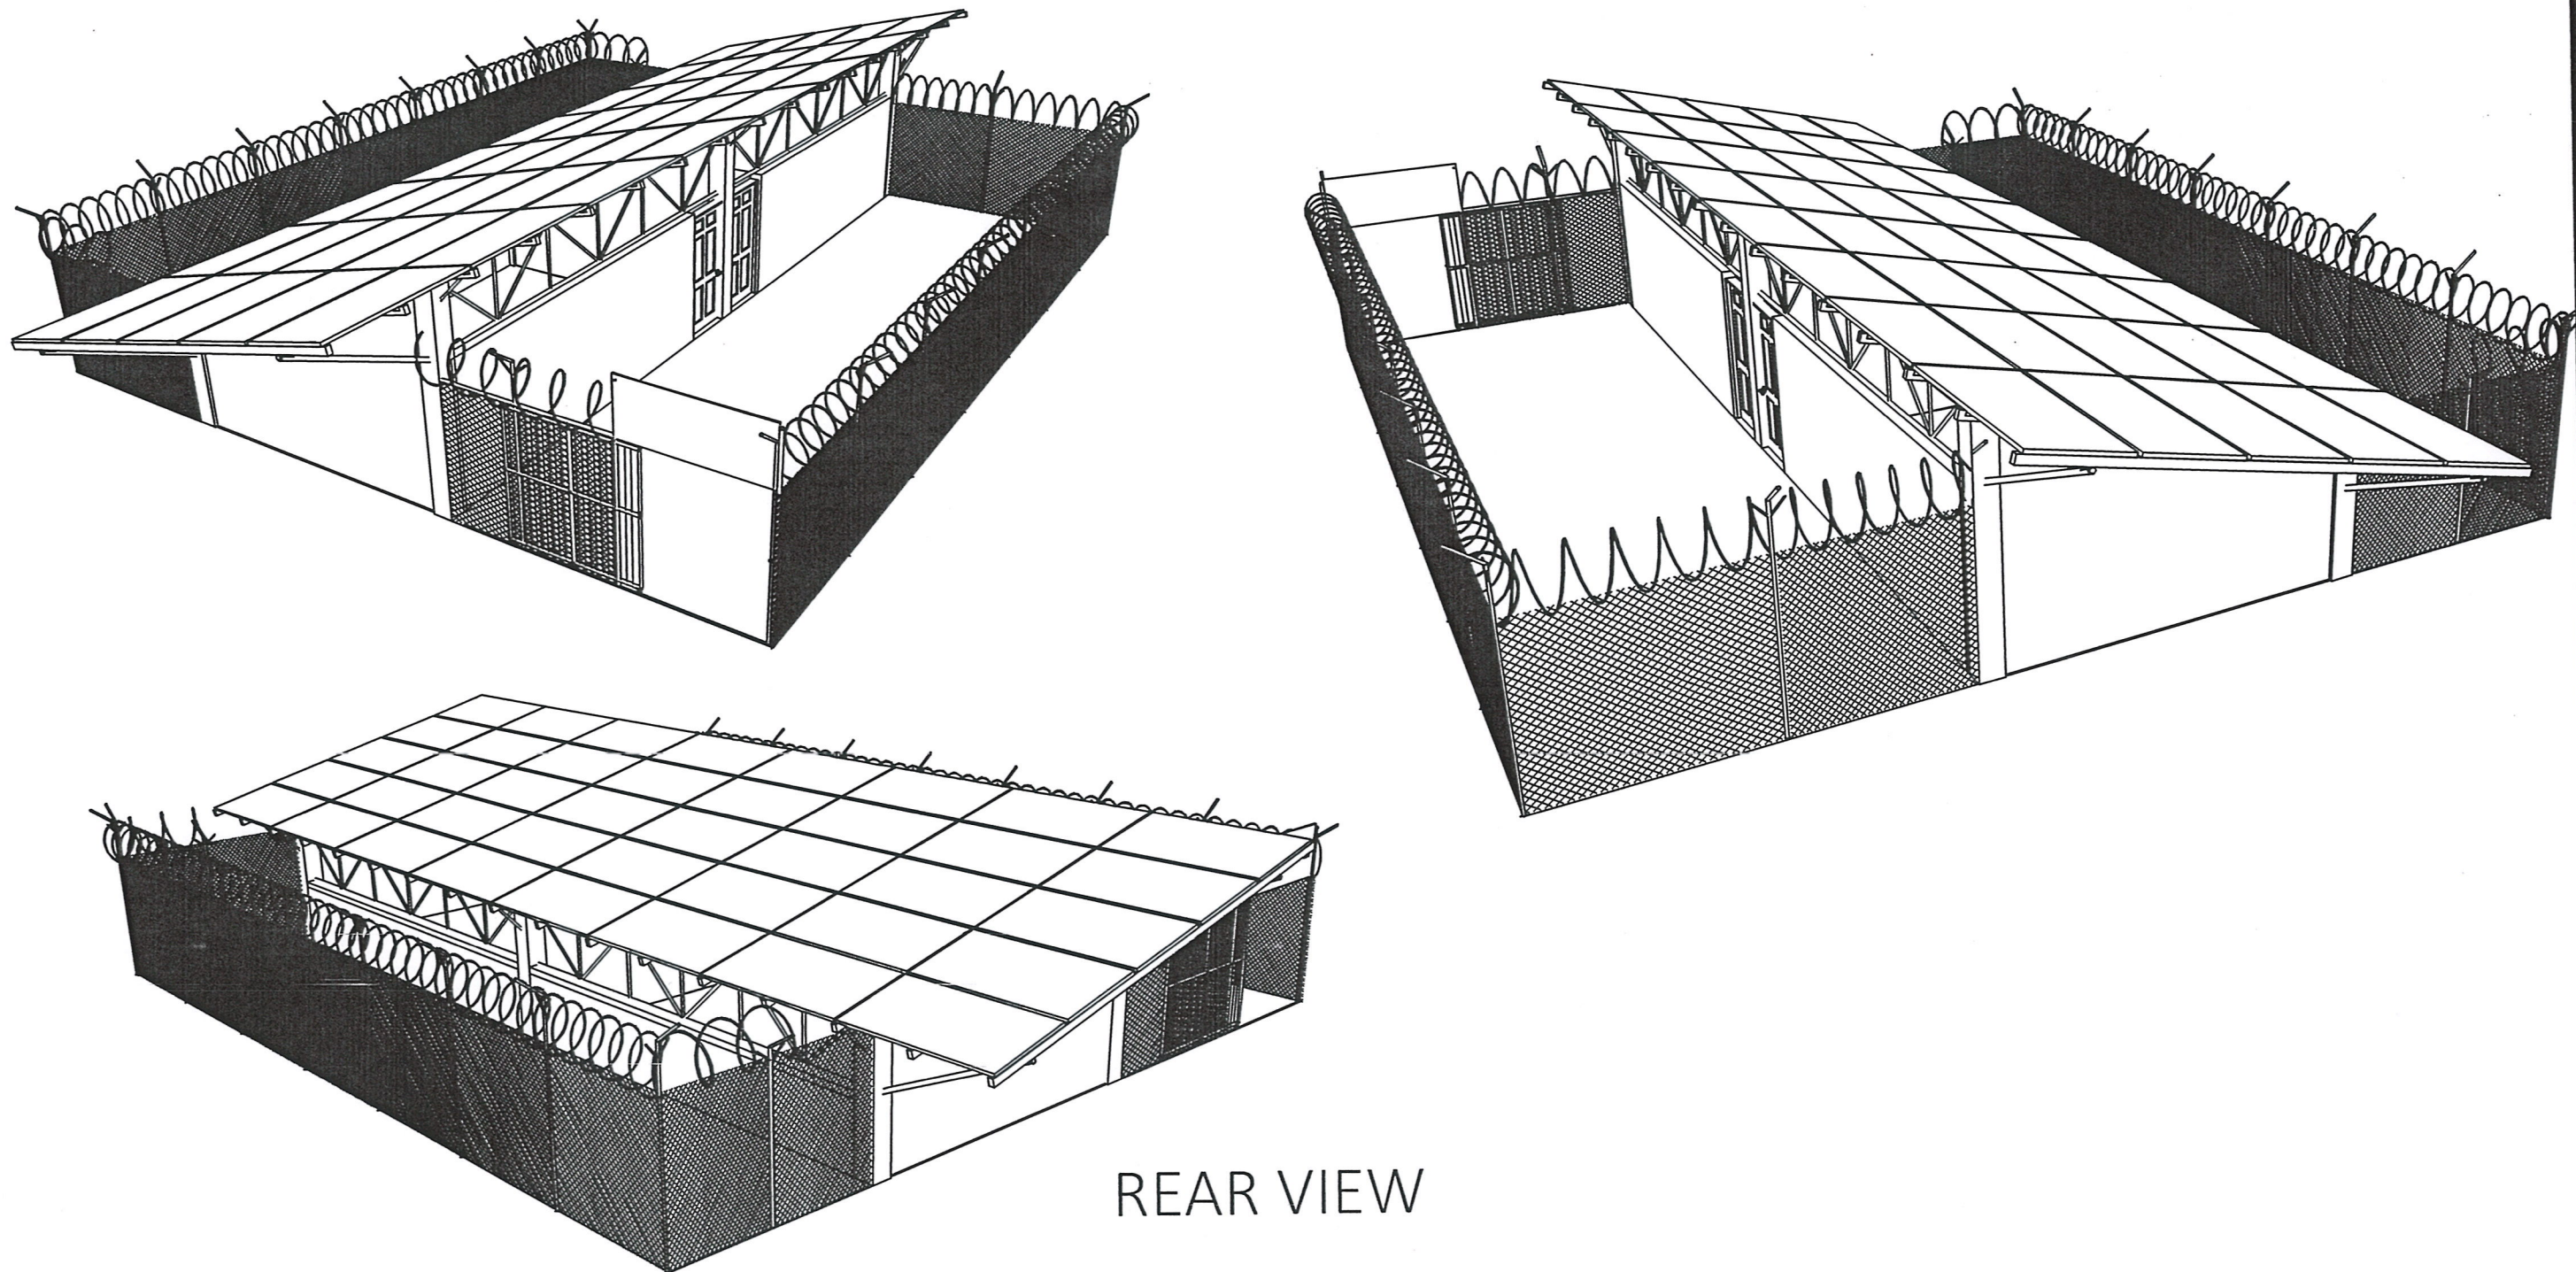

REAR VIEW



PROJECT: _____ PROJ.NO. _____

Designed : WASH Team

Description : Structure Details

مشروع مياه المعرض السوق القديم و السقايف
منظومة الطاقة الشمسيه


DWG.NO. _____ DWG.TYPE. _____ Drawing Units

Scale : As Shown

Date :

Approved : WASH Sector

CM/M

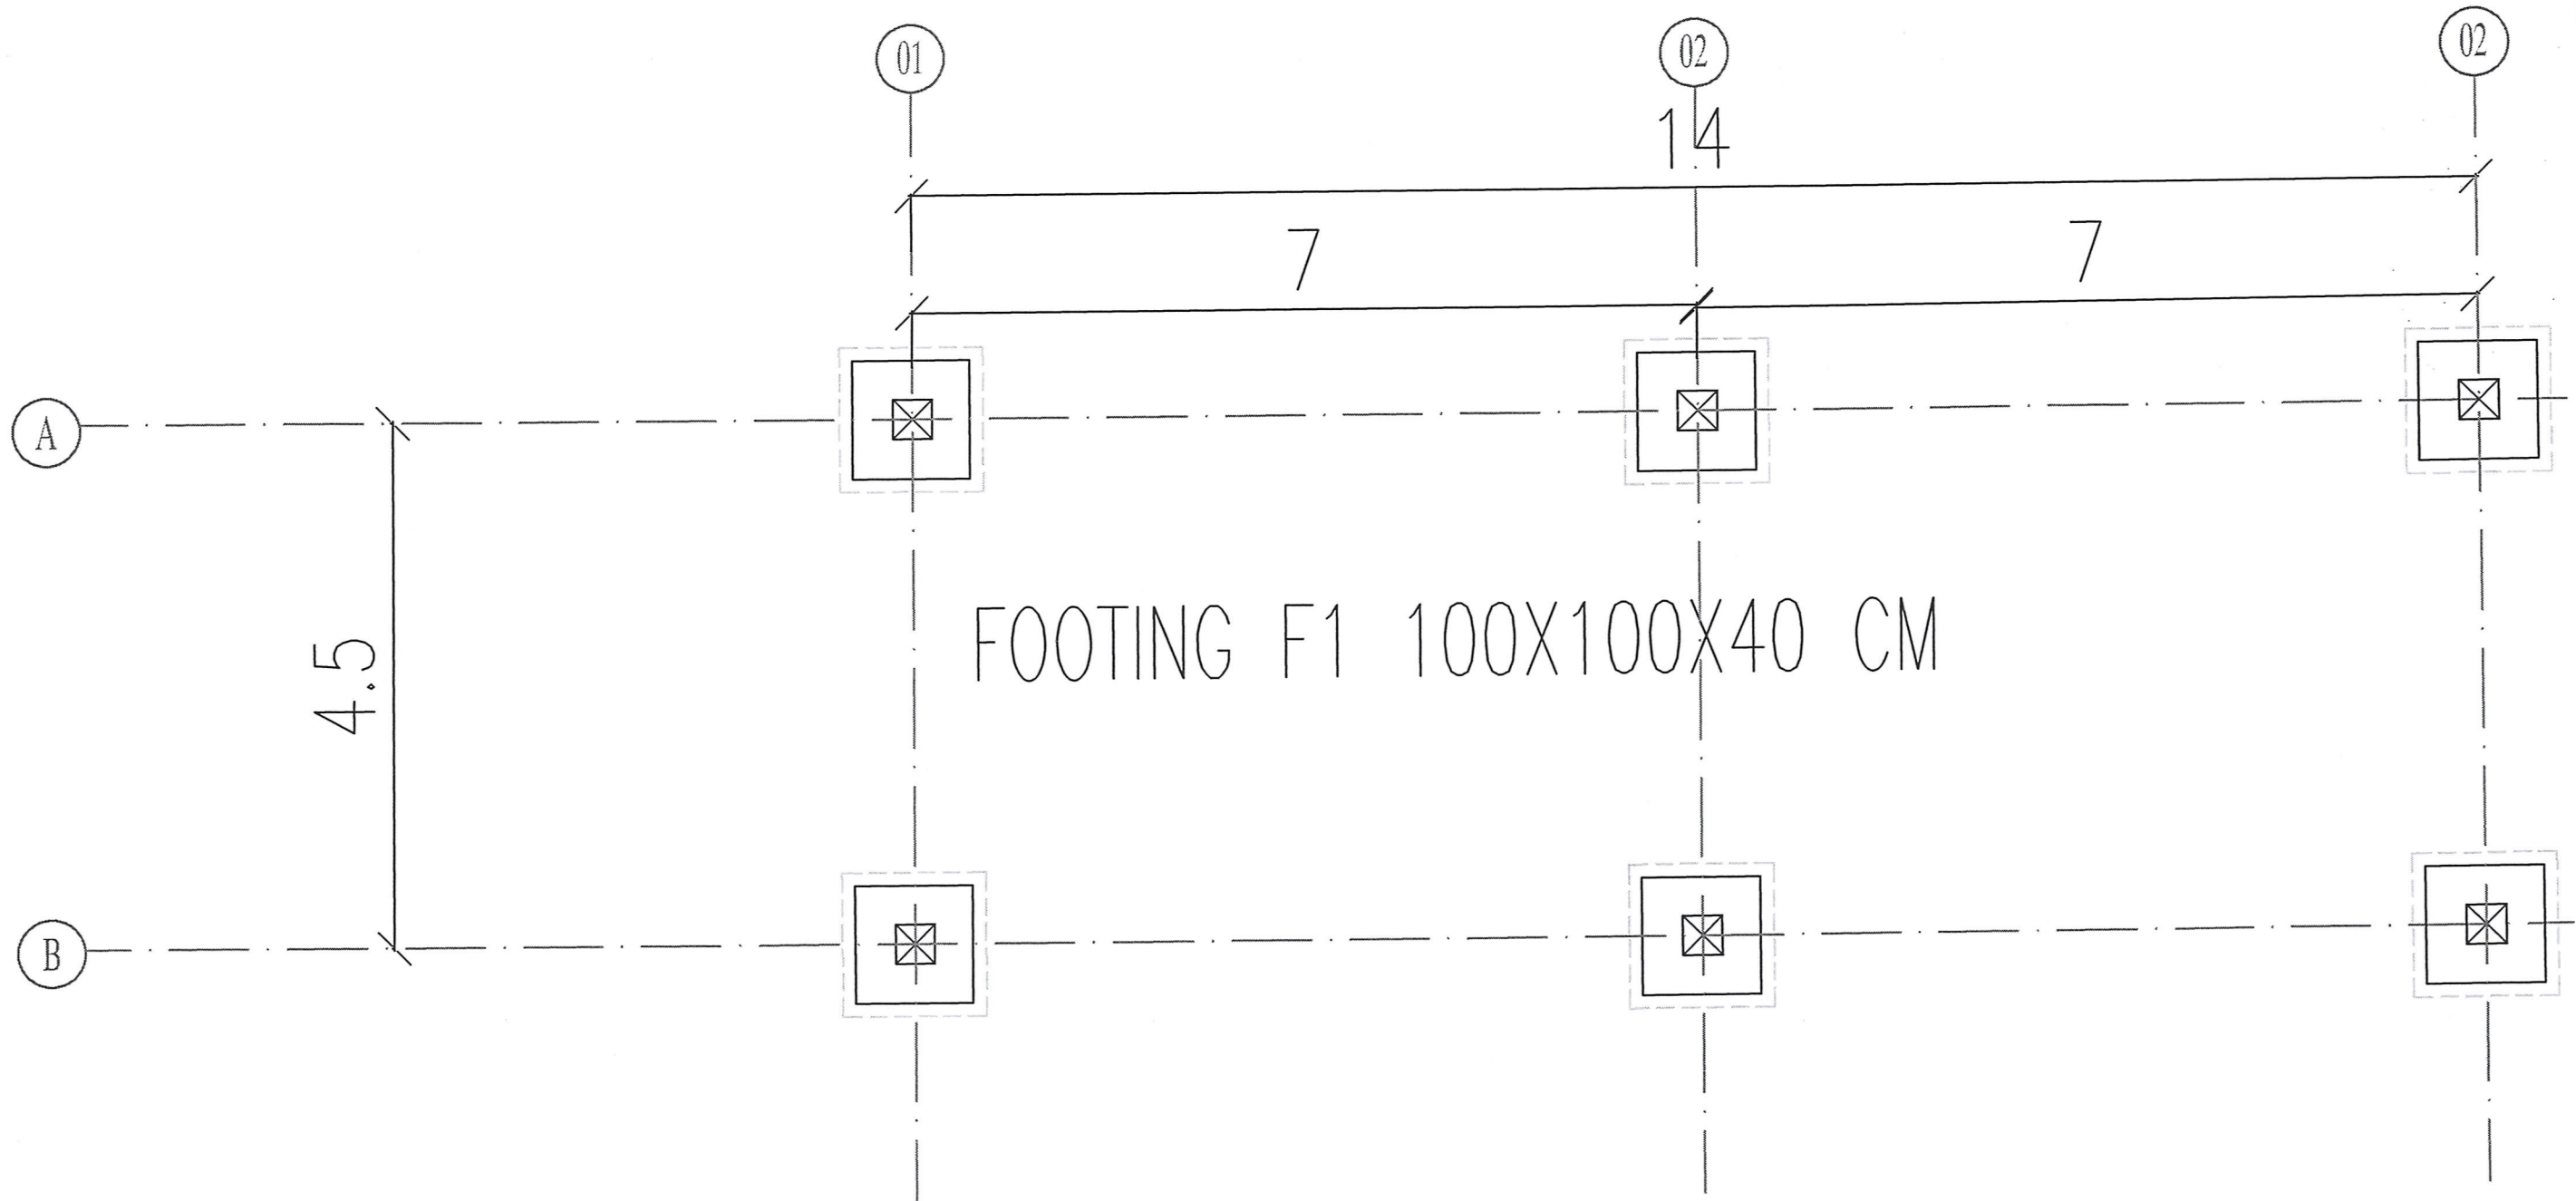

FULL FRAMING PLAN STRUCTURE DETAILS




PROJECT: _____ PROJ.NO. _____

Designed : WASH Team

Description : Structure Details

مشروع مياه المعرض السوق القديم و السقايف منظومة
الطاقة الشمسية

DWG.NO.	DWG.TYPE.	Drawing Units
		CM/M
Scale : As Shown		
Date :		
Approved : WASH Sector		

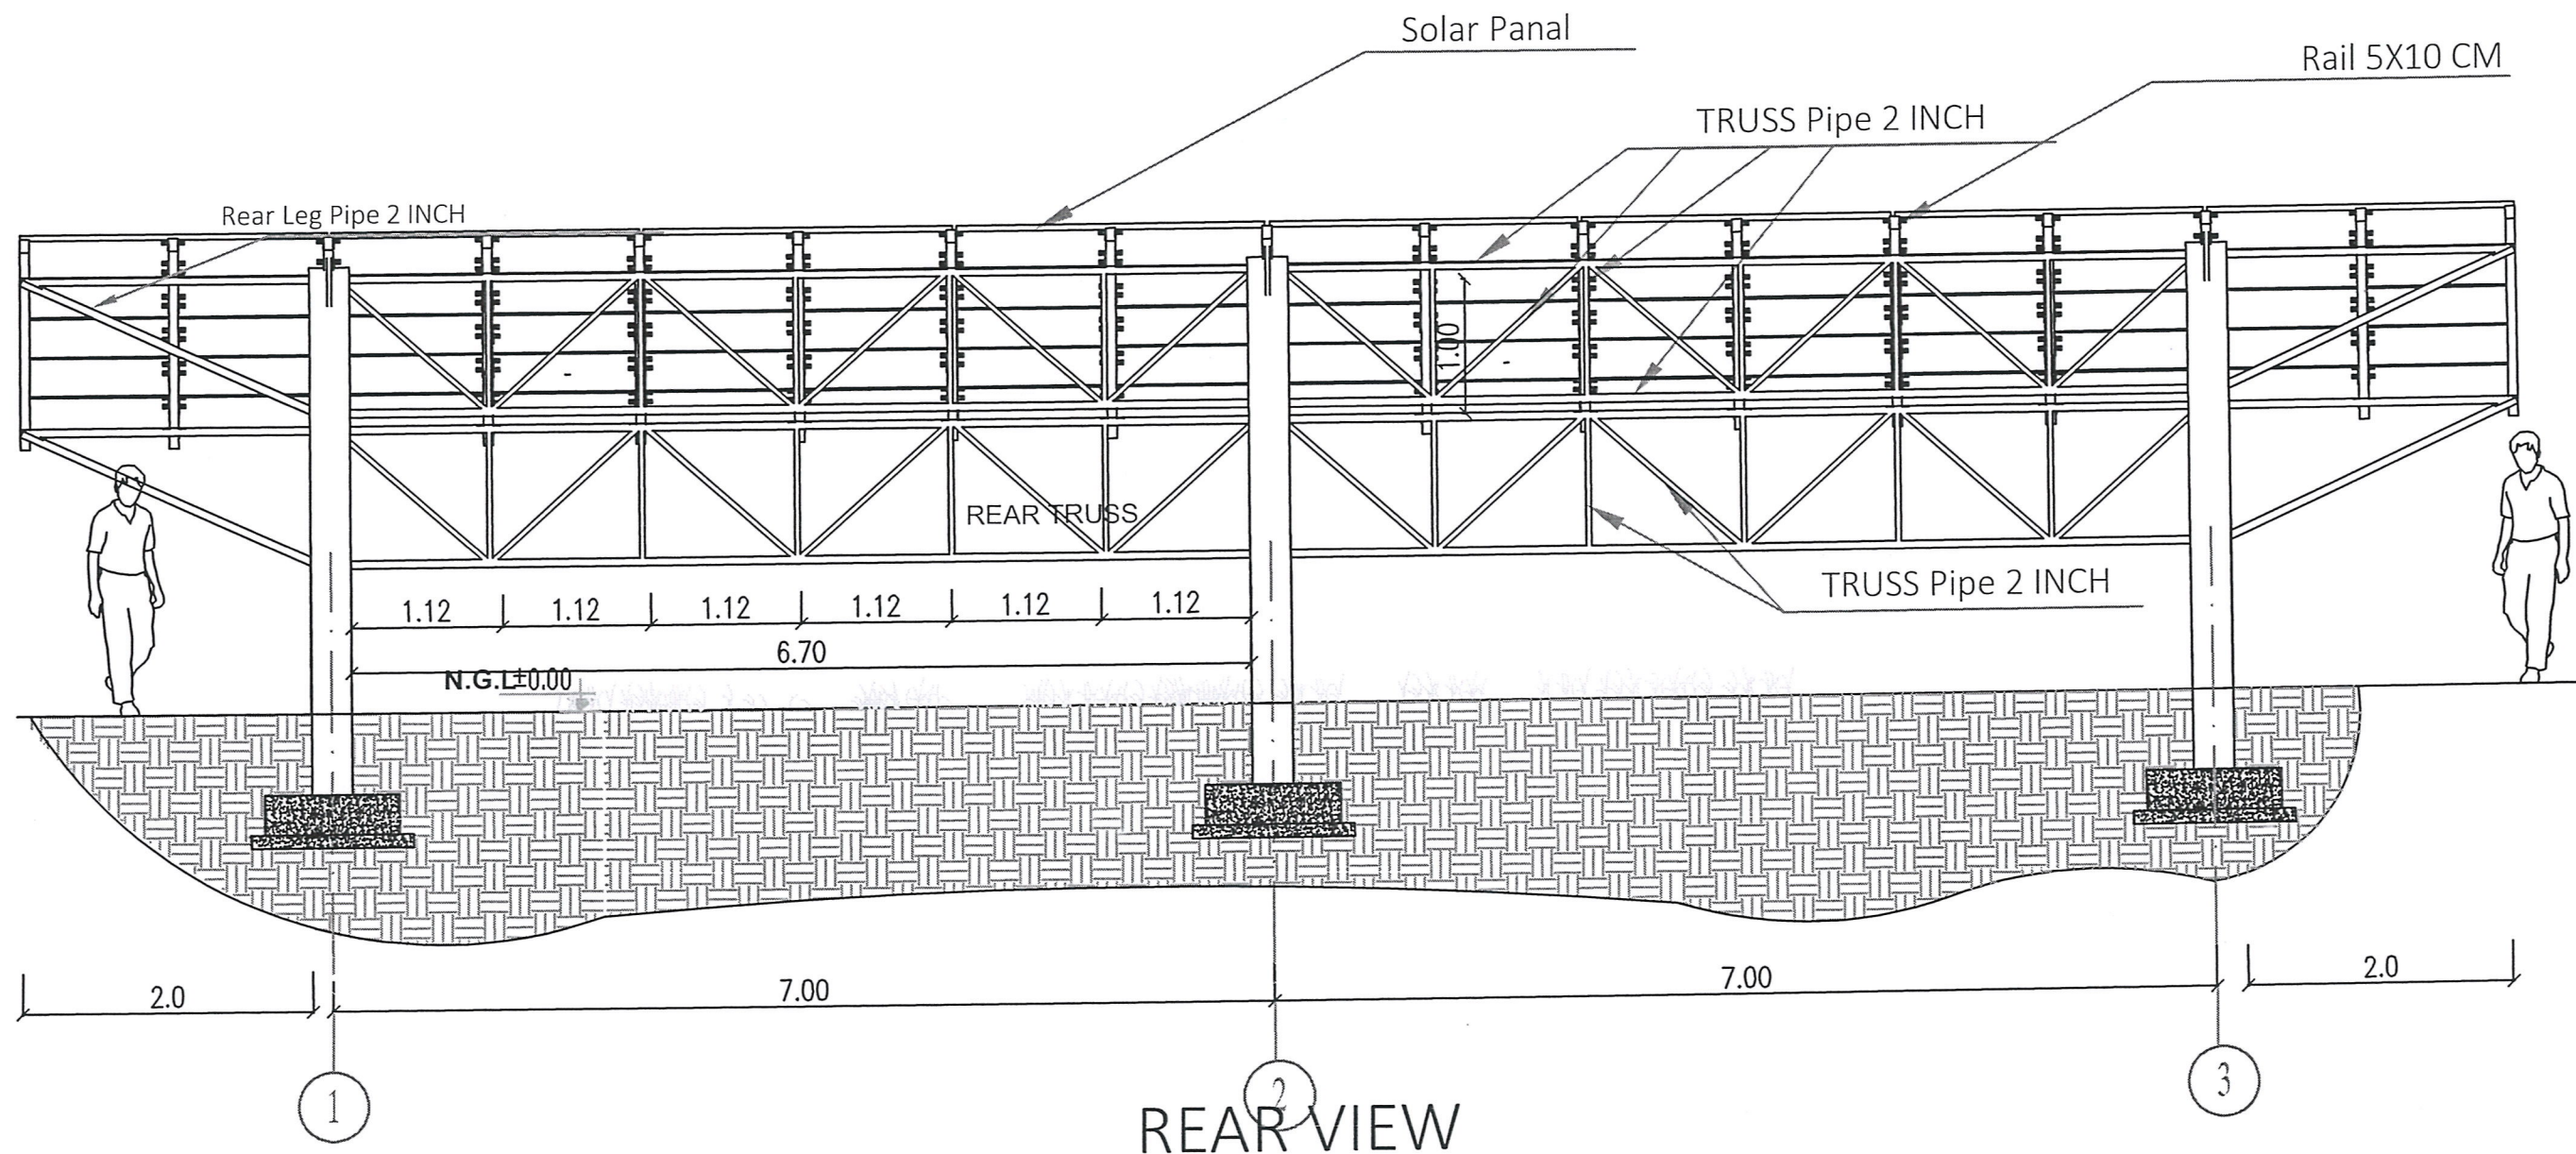

PROJECT:

PROJ.NO.

Designed : WASH Team

Description : Structure Details

مشروع مياه المعرض السوق القديم و السقايف
منظومة الطاقة الشمسيه

DWG.NO.

DWG.TYPE.

Drawing Units

Scale : As Shown

Date :

Approved : WASH Sector

CM/M

PANEL CANTILEVER(1METERS)


Rear Leg Pipe 2 INCH

Solar Panel

Rail 5X10 CM

Front Leg Pipe 2 INCH

Concrete

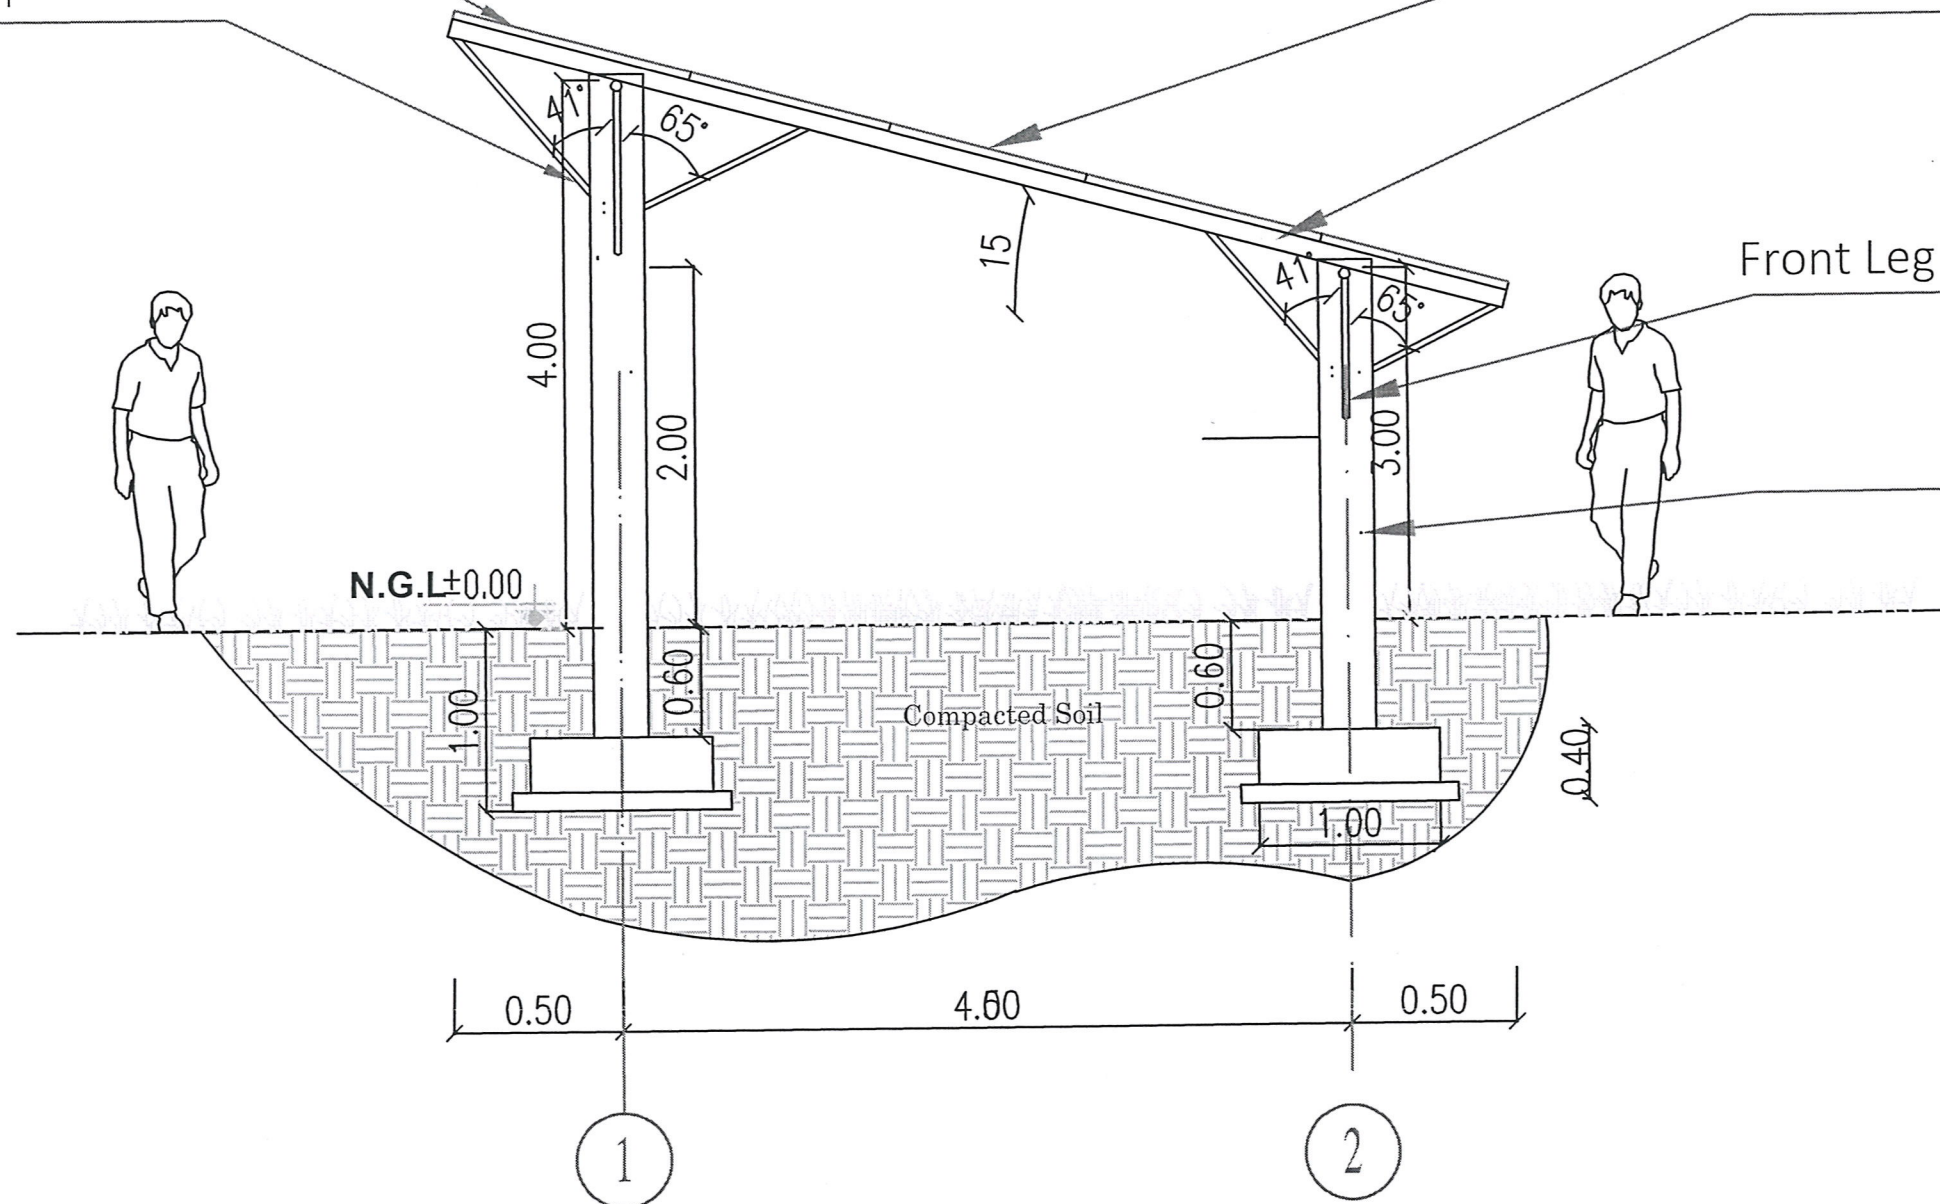

SIDE VIEW



PROJECT:

PROJ.NO.

Designed : WASH Team

Description : Structure Details

مشروع مياه المعرض السوق القديم و السقايف منظومة
الطاقة الشمسية

DWG.NO. DWG.TYPE.

Drawing Units

Scale : As Shown

Date :

CM/M

Approved : WASH Sector