


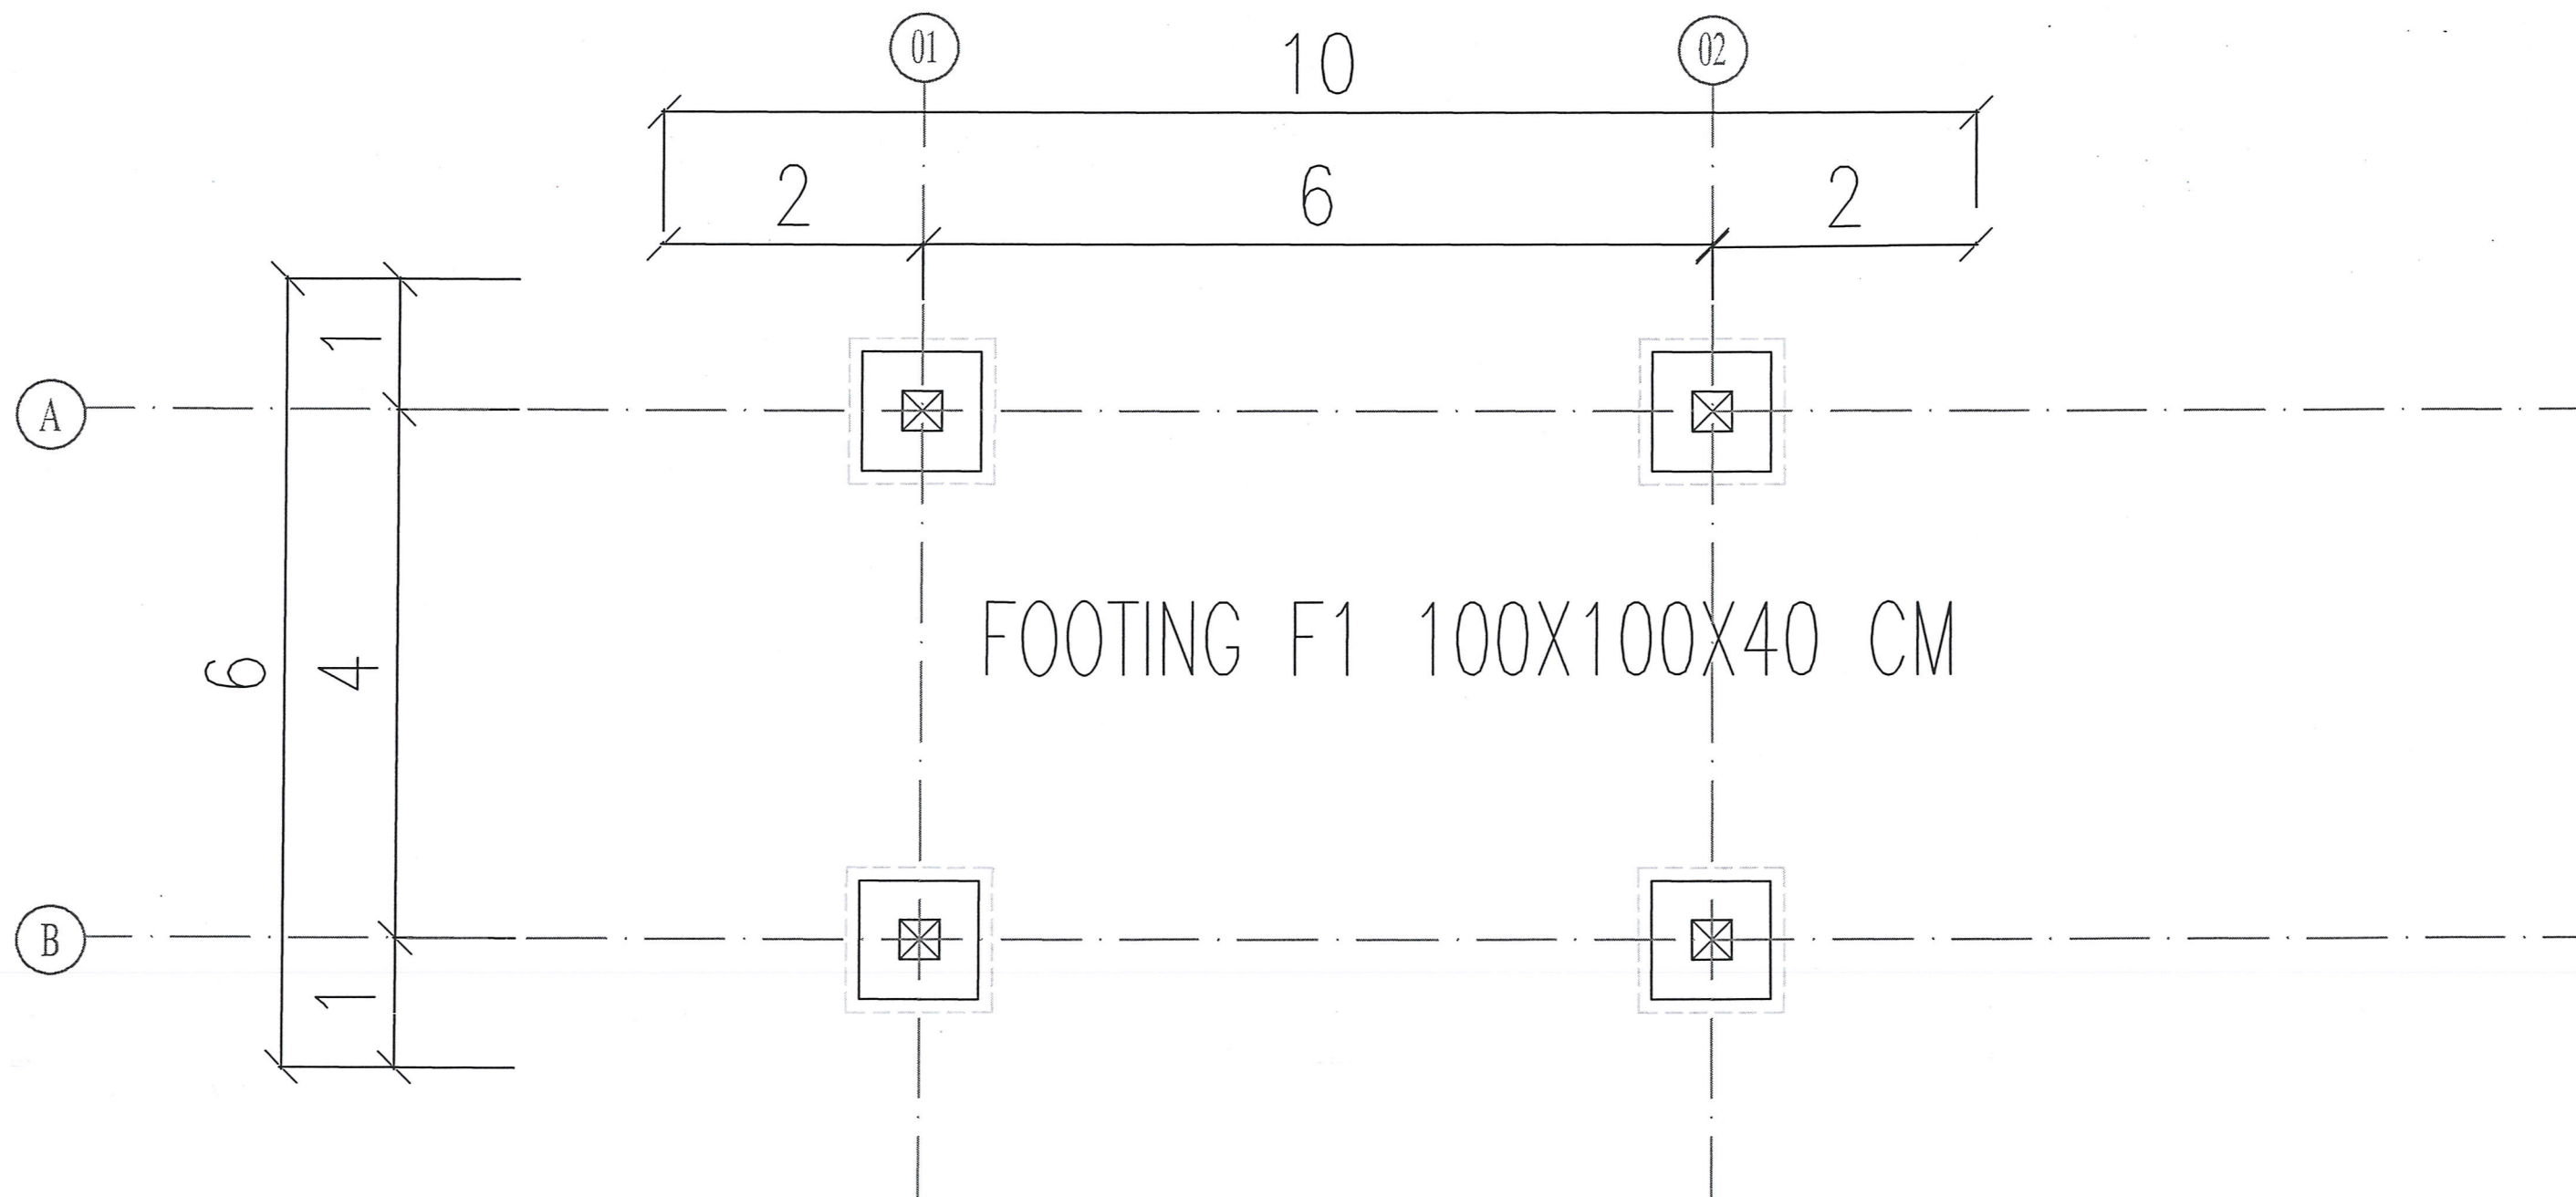

FULL FRAMING PLAN STRUCTURE DETAILS



PROJECT: PROJ.NO.


Khamis Mastaba Water Project
(Al-Marwa Villages)

Designed : WASH Team

Description : Structure Details

مشروع مياه الرصفه
منظومة الطاقة الشمسيه

DWG.NO.	DWG.TYPE.	Drawing Units
		CM/M
Scale : As Shown		
Date :		
Approved : WASH Sector		

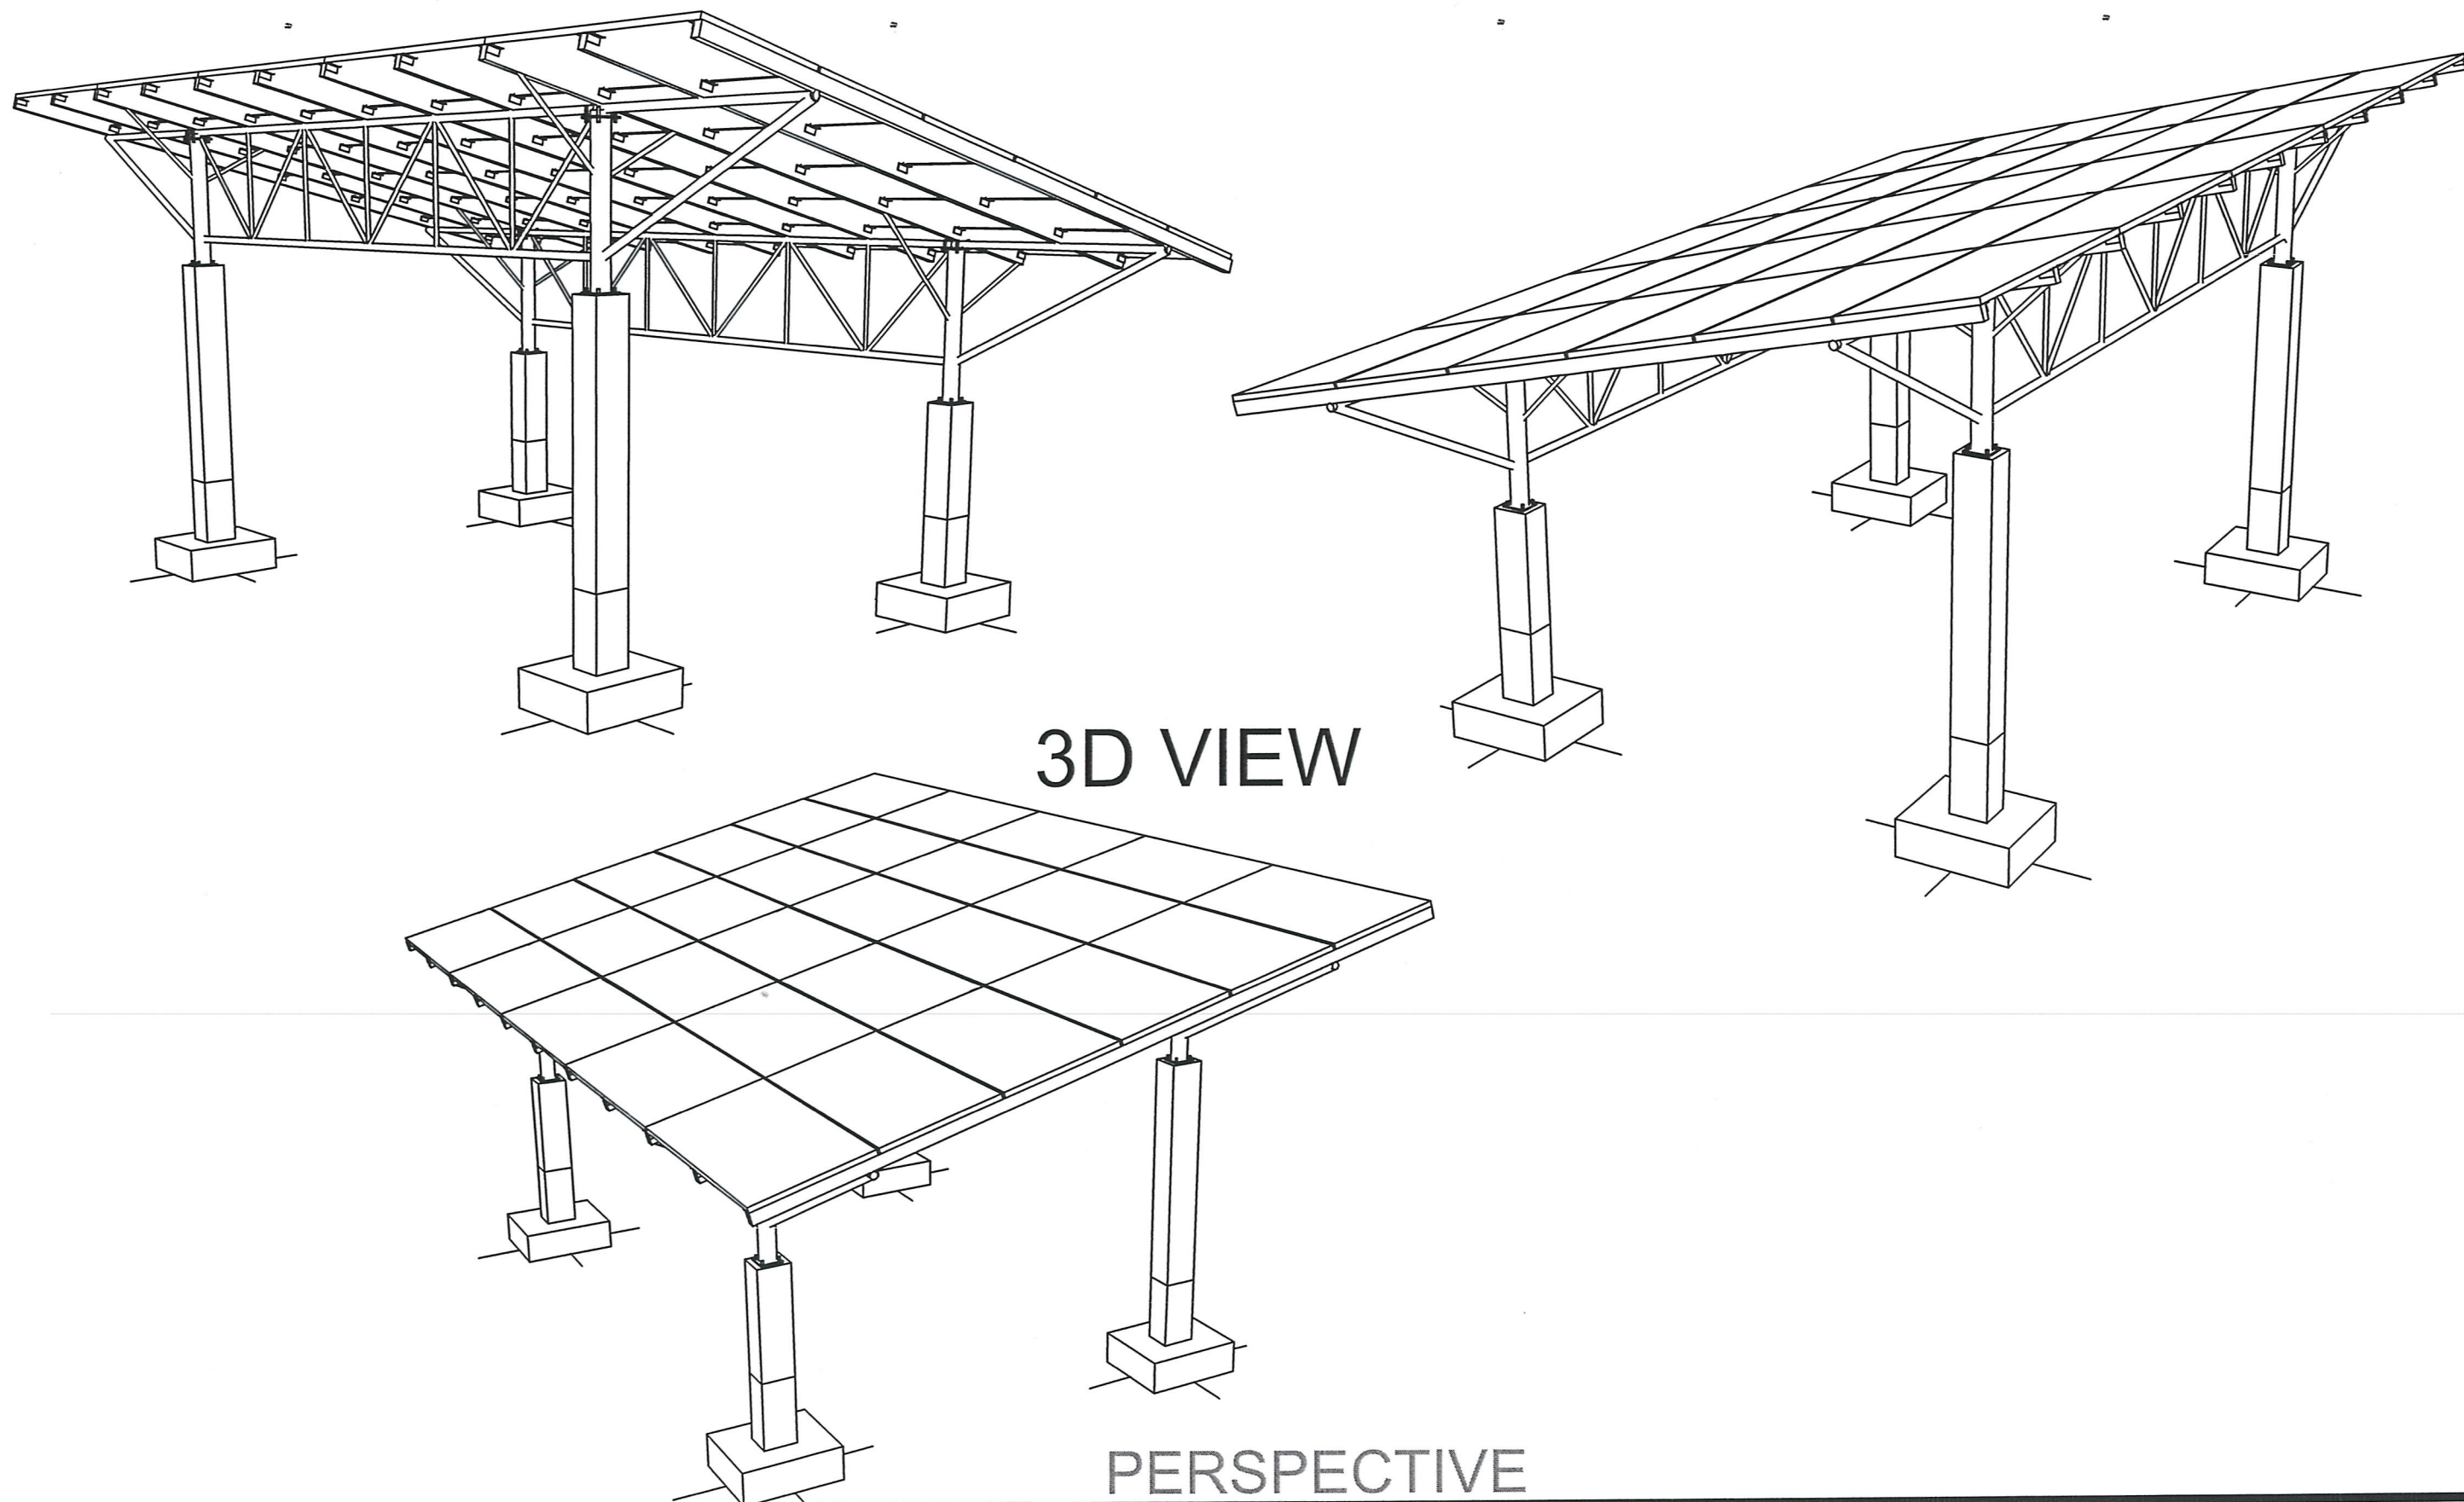

PROJECT: Khamis Mastaba Water Project
(Al-Marwa Villages)

PROJ.NO.

Designed : WASH Team

Description : Structure Details

مشروع مياه الرصفه منظومة الطاقة الشمسيه

DWG.NO. DWG.TYPE.


Drawing Units

Scale : As Shown

Date :

CM/M

Approved : WASH Sector

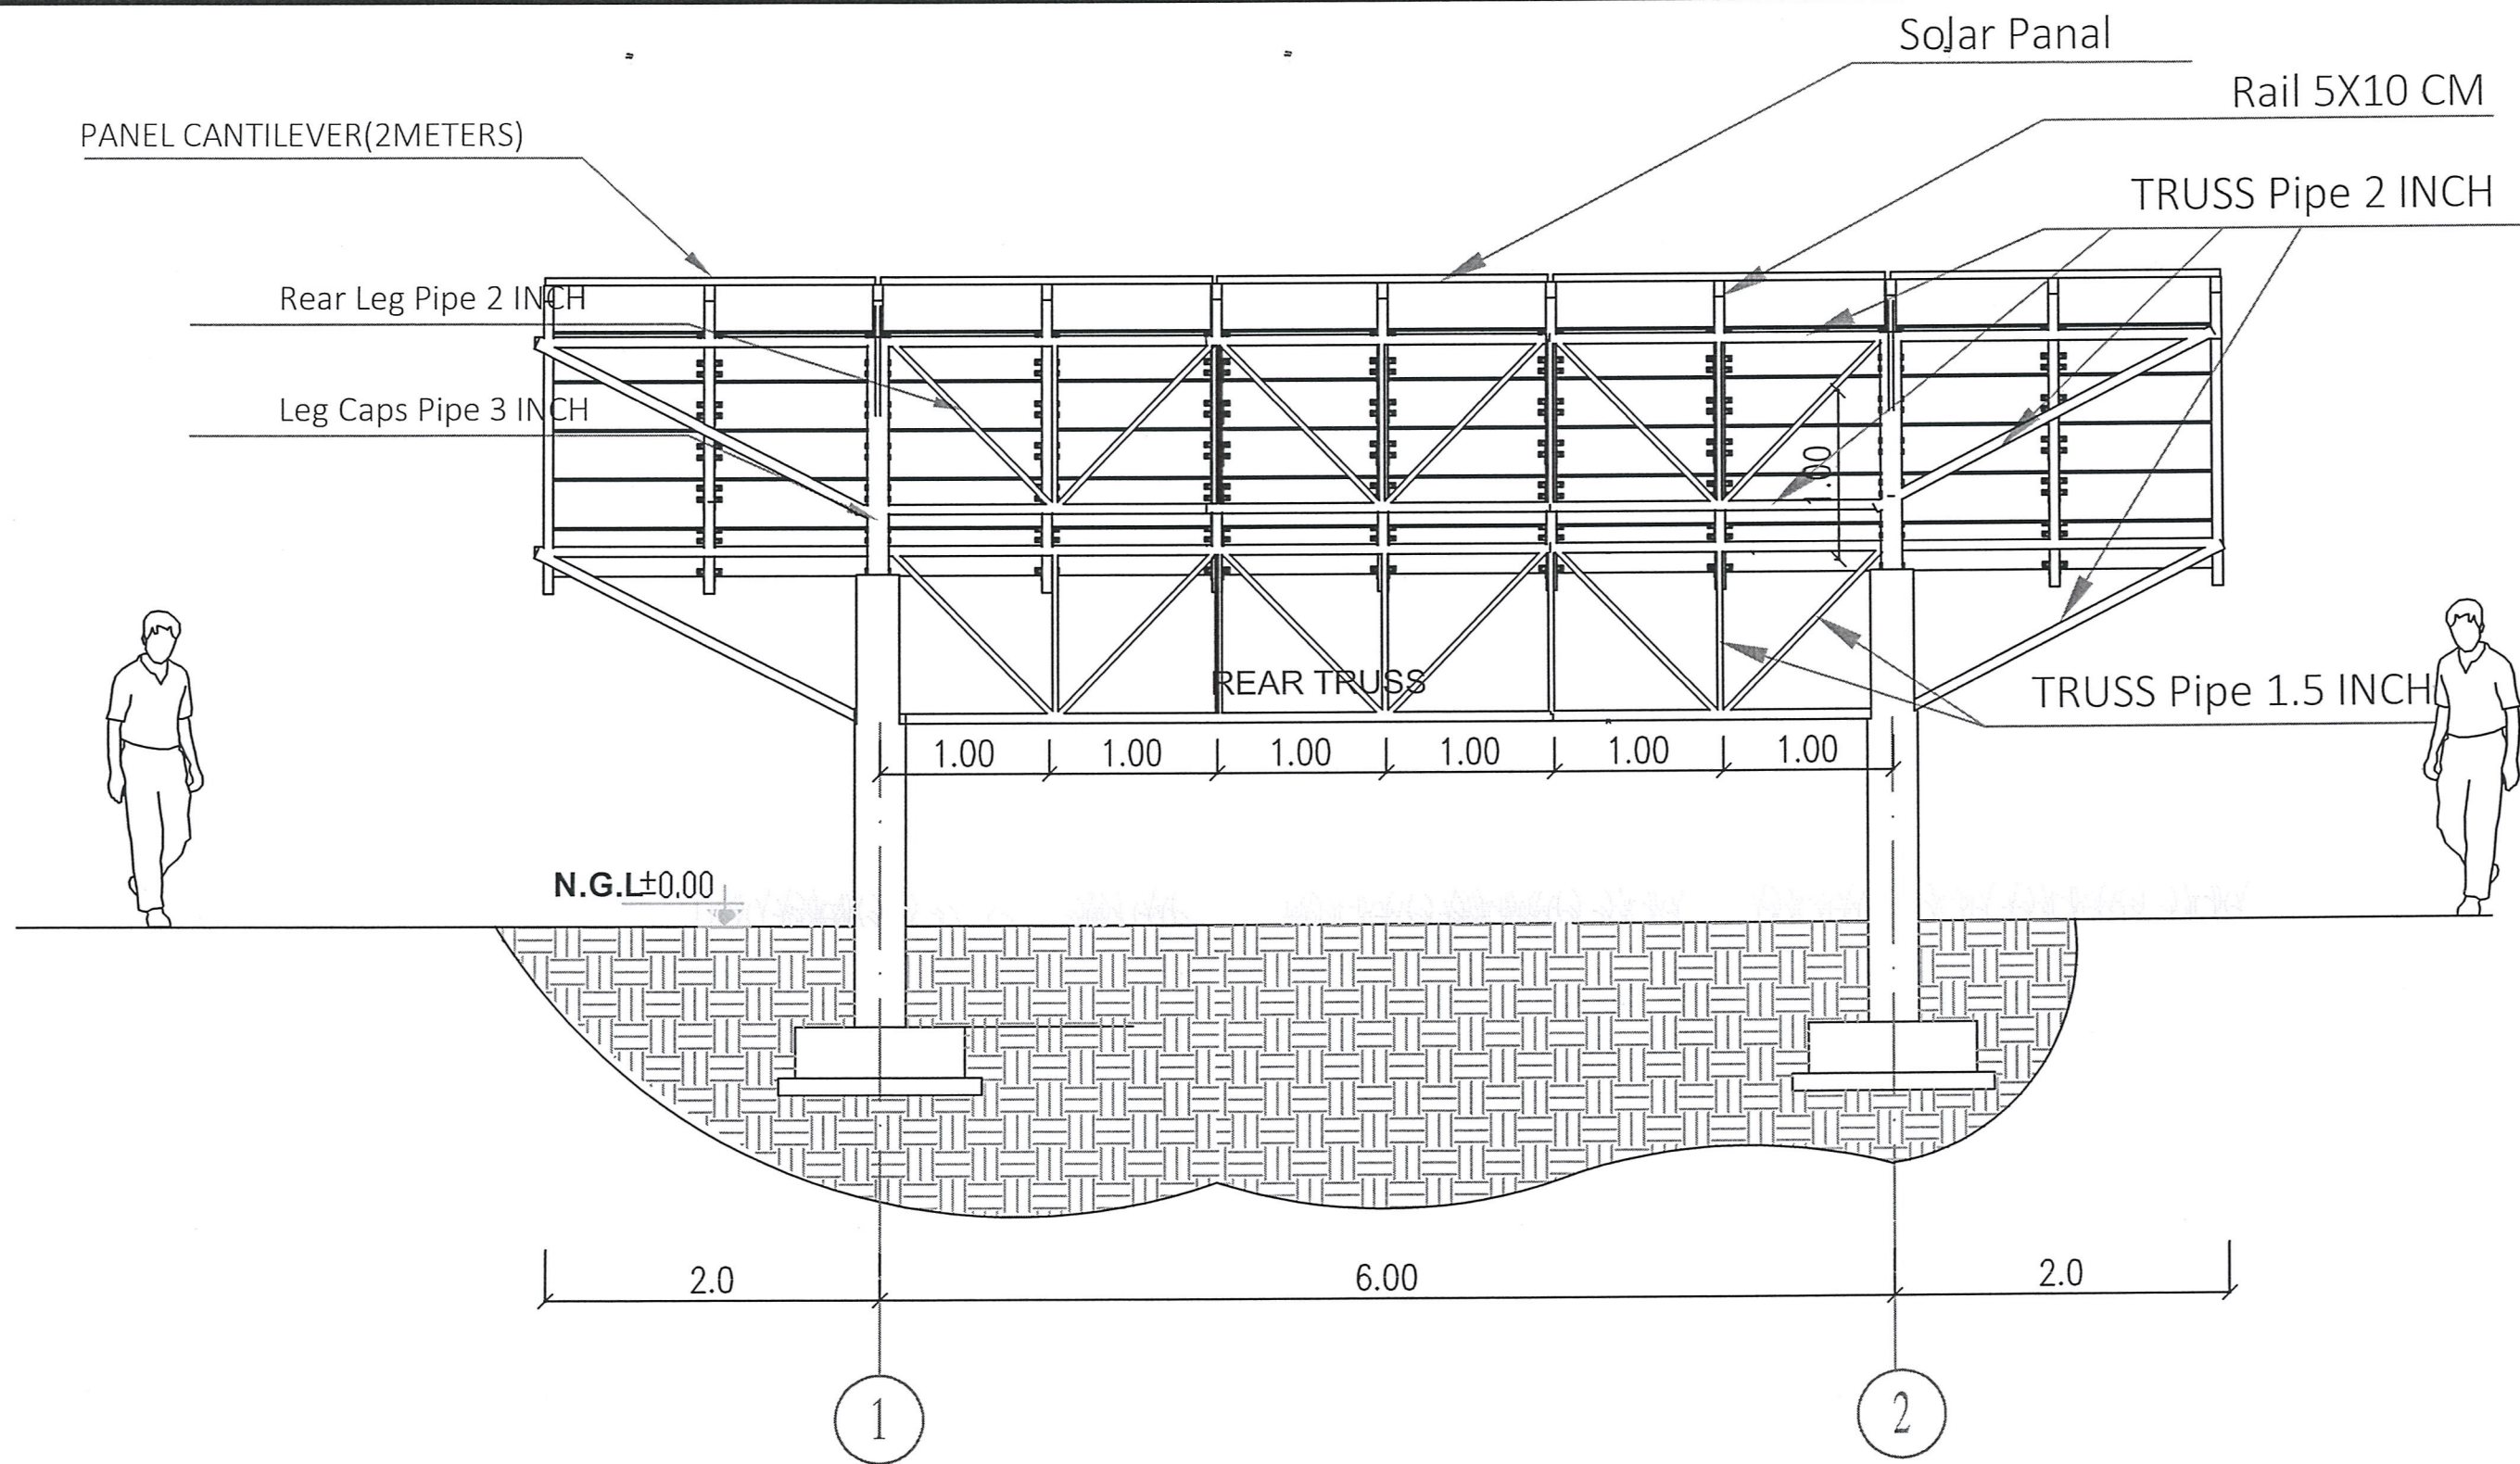

REAR VIEW



PROJECT: Khamis Mastaba Water Project
(Al-Marwa Villages)

PROJ.NO.

Designed : WASH Team

Description : Structure Details

مشروع مياه الرصفه منظومة الطاقة الشمسيه

DWG.NO. DWG.TYPE.

Drawing Units

Scale : As Shown

Date :

CM/M

Approved : WASH Sector