


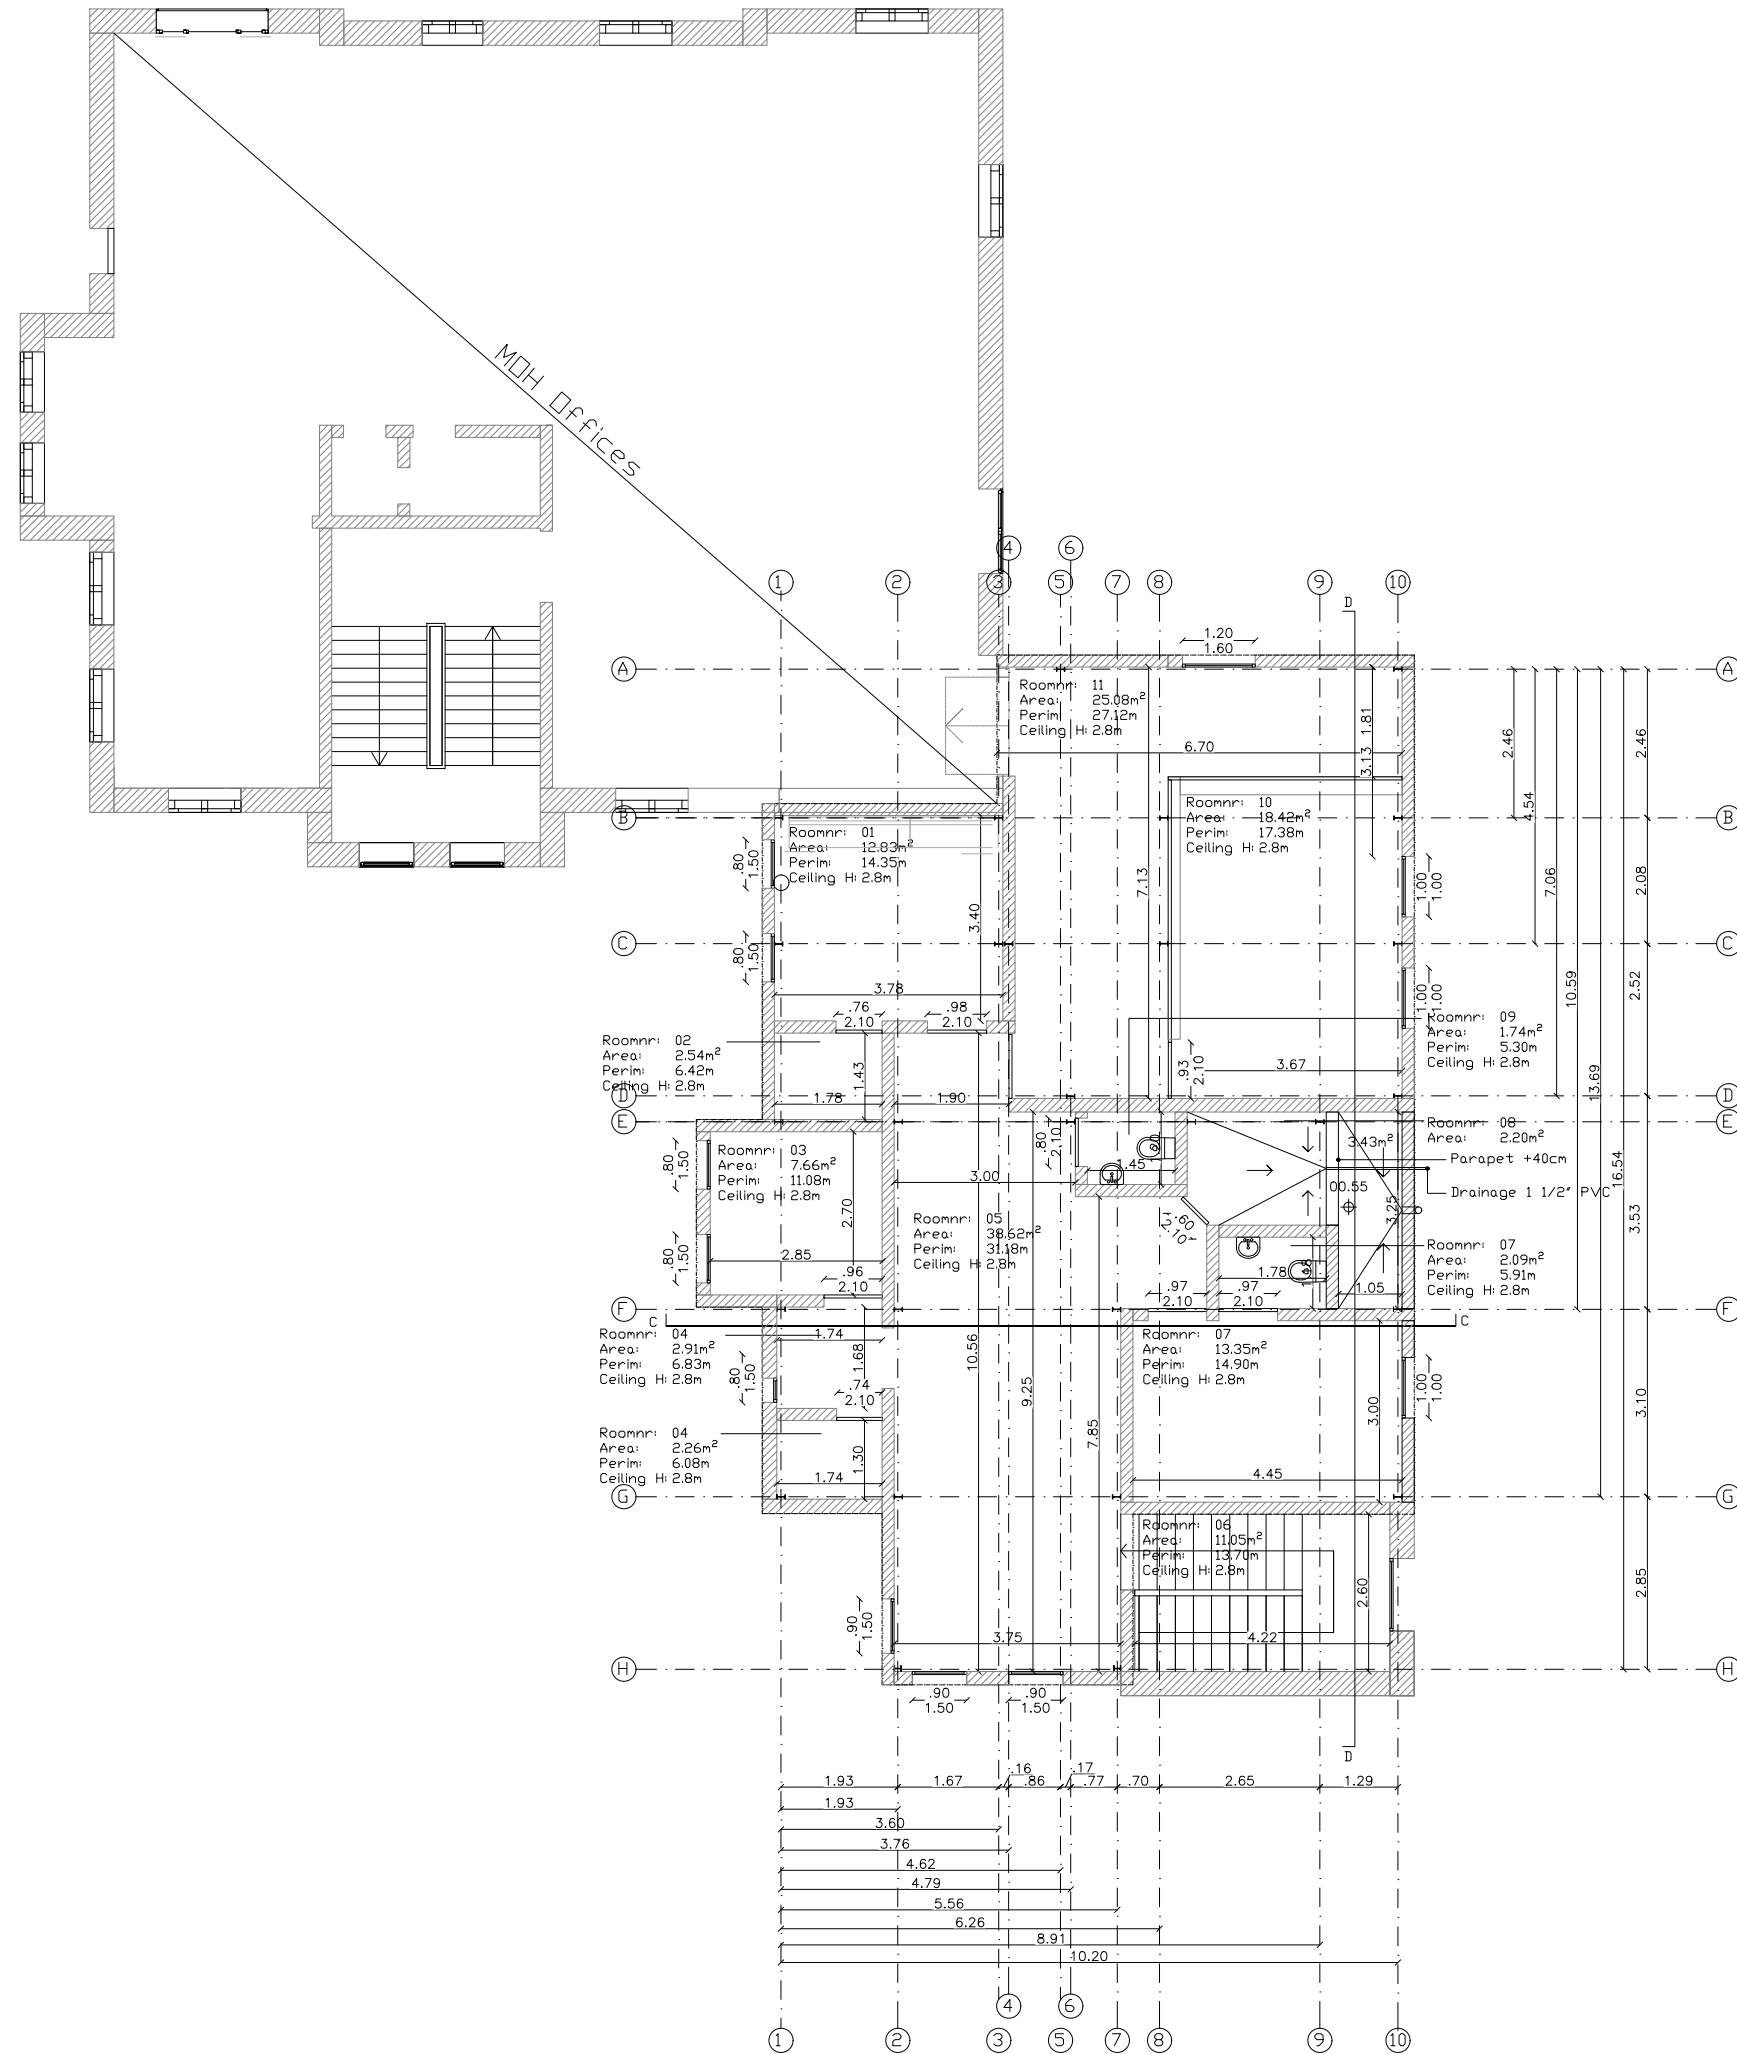

Rev	Description	Date	Dgn	Chk	App
-	FIRST ISSUE	12/07/26	CM		

Developer


MSF OCB Yemen

Project Title
Mocha Hospital

Contractor
Mocha hospital

Originator
Mocha hospital

Drawing Title
CEmONC roof - Floor plan

Drawn	CONST.MAN	Scale	A3, 1:125
Designed	CONST.MAN	Status	Issued for tender
Checked			
Approved			

Drawing No. CEmONC-ARC-PLN-01 Rev -